


BROOKENS PODS 200  
2 MULTI-ZONE RTU REPLACEMENT PROJECT ITB #2017-002  
CHAMPAIGN COUNTY ADMINISTRATIVE SERVICES  
1776 EAST WASHINGTON STREET  
URBANA, ILLINOIS 61801




CHAMPAIGN COUNTY  
ADMINISTRATIVE SERVICES  
1776 EAST WASHINGTON STREET  
URBANA, ILLINOIS 61802  
PHONE: (217) 384-3776 - FAX: (217) 384-3896

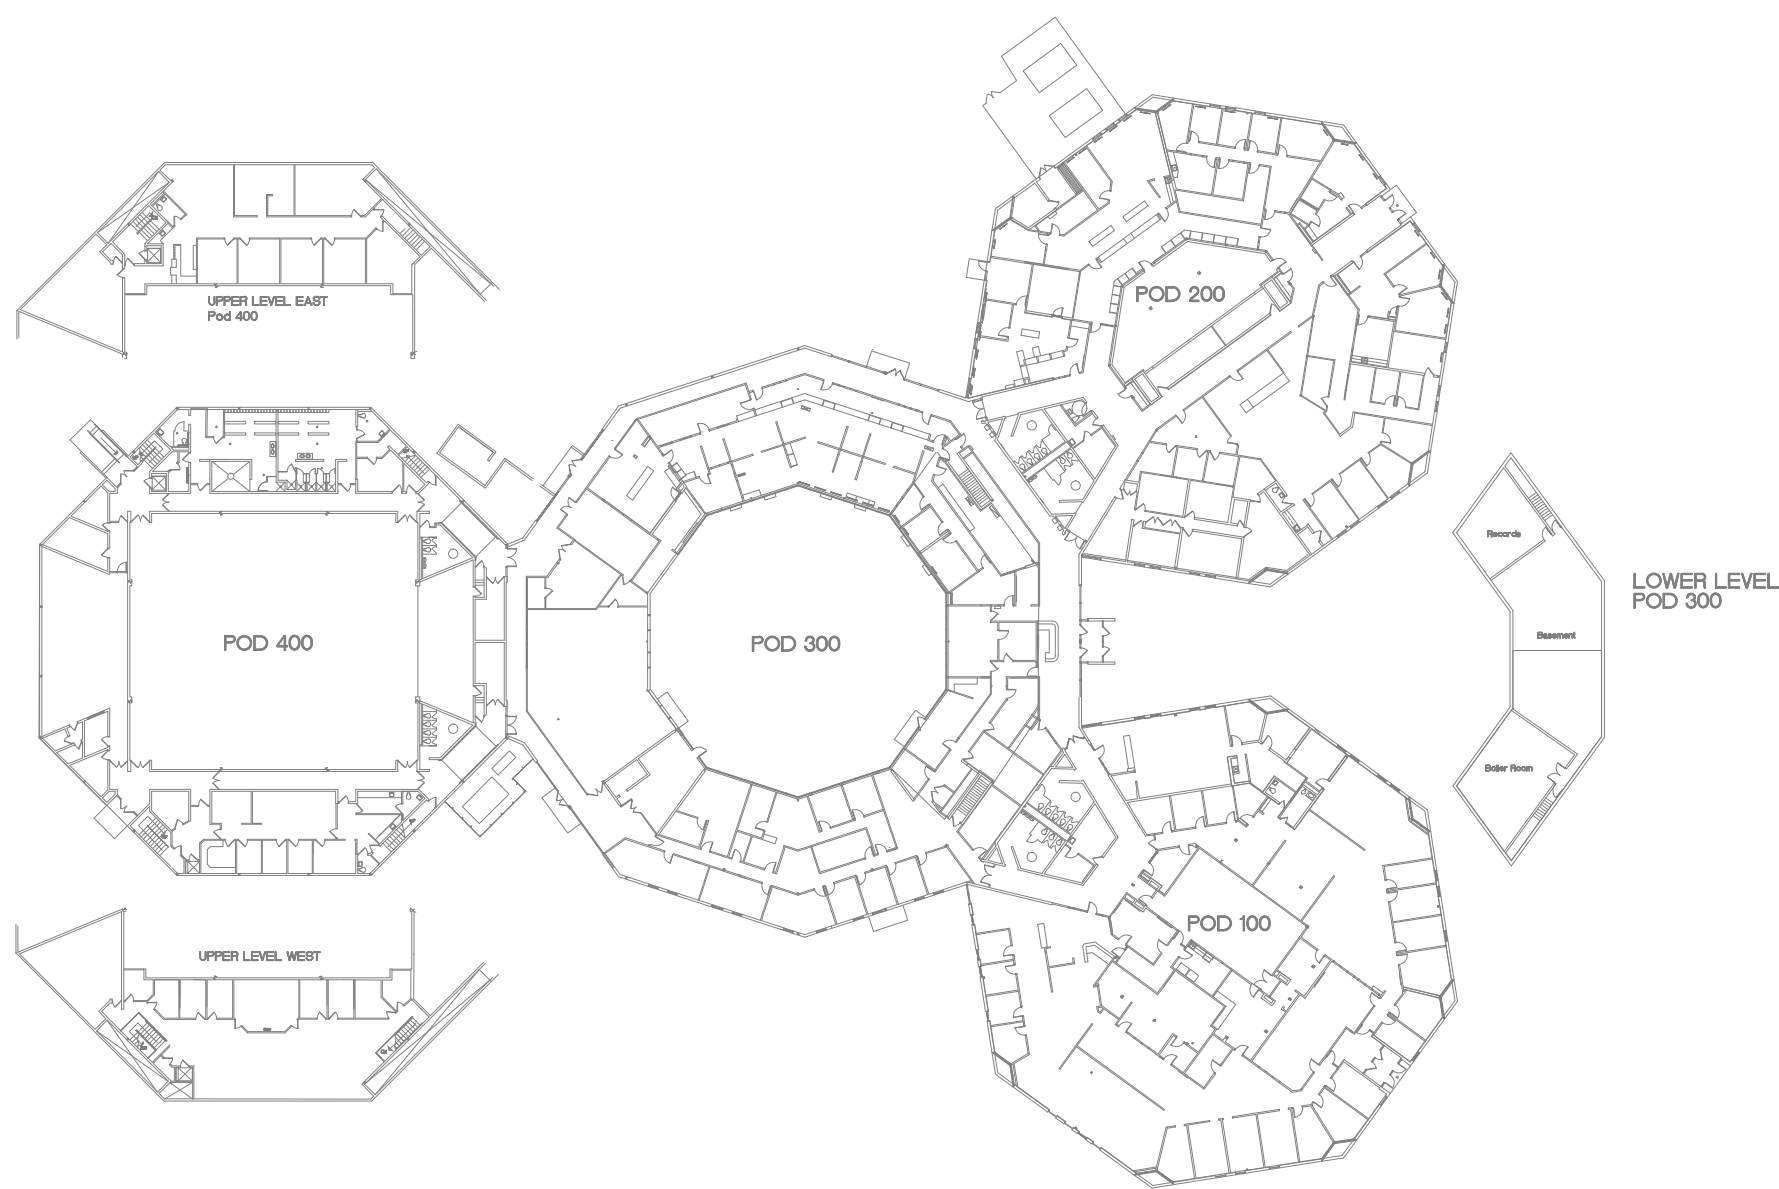

KEY PLAN  
NO SCALE

INDEX TO SHEETS

- C-01 COVER SHEET
- MED-01 PARTIAL FLOOR PLAN - POD 200 - MECH/ELEC - DEMOLITION
- ME-01 PARTIAL FLOOR PLAN - POD 200 - MECH/ELEC - NEW WORK
- ME-02 SCHEDULES + DETAILS

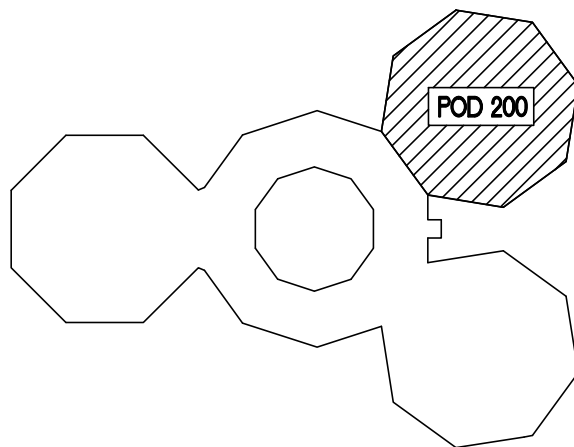

KEY PLAN  
NO SCALE

DATE	NO.	DESCRIPTION




ENGINEERS AND ASSOCIATES, INC.  
Mechanical & Electrical Consulting Engineers

1615 South Neil Street  
Champaign, Illinois 61820  
217-366-0536 Business  
217-366-1092 Fax

Sheet Title:COVER SHEET

BROOKENS ROOFTOP UNIT REPLACEMENT  
Champaign County Administrative Services  
1776 East Washington, Urbana, Illinois 61801

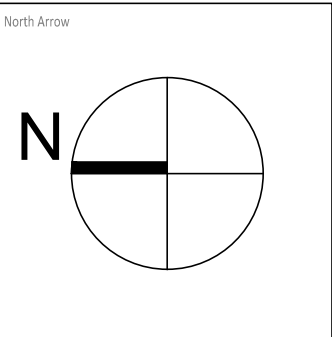

Designed: JGM	Approved: JGM
Drawn: CMS	Approved: JGM
Checked: JGM	Approved: JGM

DATE: May 4, 2017
SCALE: 1/8" = 1'-0"
PROJECT: 7058

SHEET: C-01
----------------