

Date: June 2, 2021  
To: Plan Holders  
Subject: Addendum No. 1 to the Bidding Documents for: ITB No. 2021-004

Hail Damaged HVAC Replacement Project  
Brookens Administrative Center  
1776 East Washington Street  
Urbana, Illinois

Addendum No. 1 becomes a part of the bidding and contract documents and modifies the original bidding documents, dated May 5, 2021. Acknowledge receipt of Addendum No. 1 in the space provided on Bid Form. **FAILURE TO DO SO MAY SUBJECT BIDDER TO DISQUALIFICATION.**

Drawings

1. M-100 - BROOKENS POD 100 HVAC ROOF REPLACEMENT
  - a. ADD Keynote No. 4 to RTU-1, 2, 3, 4, 5, 6 7.
2. M-101 - BROOKENS POD 200 HVAC ROOF PLAN
  - a. REMOVE Keynotes No. 3 and No. 4 from Pod 200 YMH Unit.
  - b. REVISE Keynotes No. 3 and No. 4 to read "Keynote note used."
3. M-105 - CHAMPAIGN COUNTY COURTHOUSE HVAC ROOF PLAN
  - a. REVISE Keynotes No. 1 and No. 2. See attached sheet.

Bids are due Friday, June 4, 2021 at 1:00 p.m. central time at the Lyle Shields Conference Room, Brookens Administrative Center, 1776 East Washington, Urbana, Illinois.

Respectfully submitted,


GHR Engineers and Associates, Inc.

Richard Van Note  
Project Manager  
Phone: 217-356-0536  
Fax: 217-356-1092

RCVN/smh

Addendum No. 1 - Hail Damaged HVAC Replacement Project.wpd

FILE: H:\GHR Projects\7321 - Champaign County Administrative Services - Brookens - Hail Damage\HVAC\01 - Worksheets\7321 - M-105.dwg  
 PRINTED: 06/02/2021

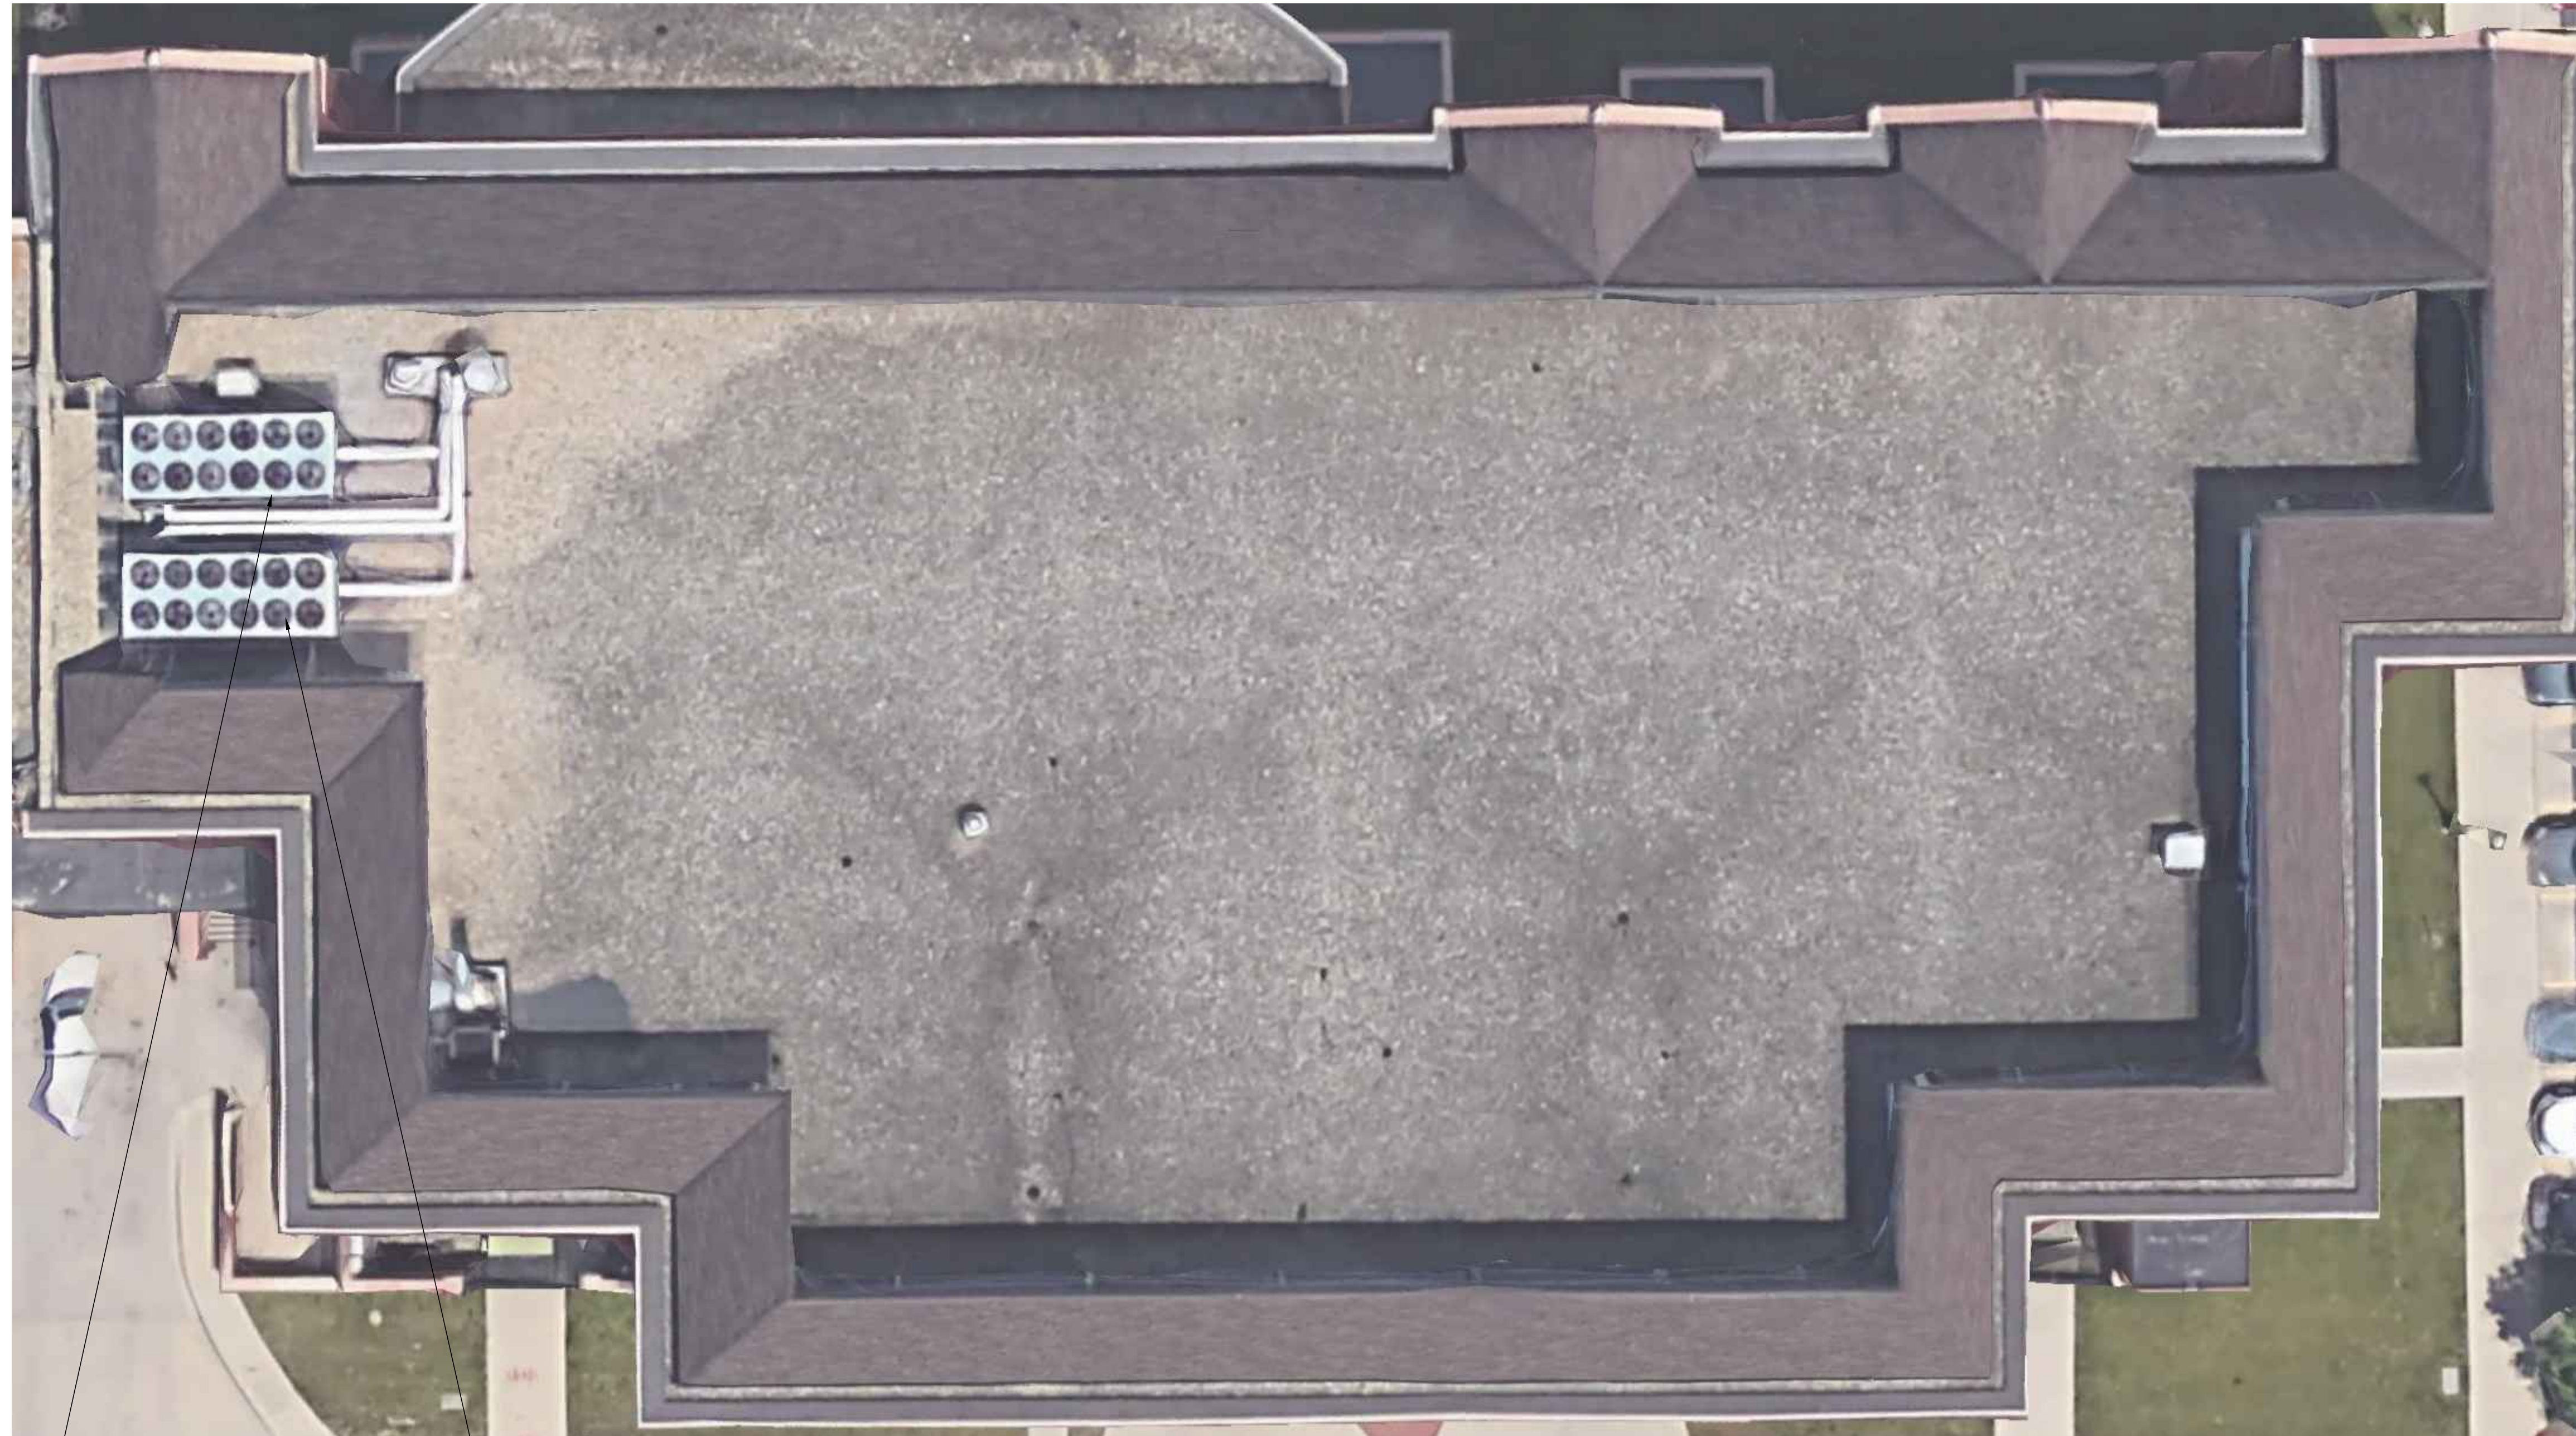

- KEYED NOTES - (FOR THIS PLAN ONLY)**
- 1. REMOVE CONDENSER COIL FROM EXISTING AIR COOLED CONDENSER. REMOVE CONDENSING UNIT FAN MOTORS AND CONDENSER FAN BLADES. INSTALL NEW COIL, NEW CONDENSER FAN MOTORS, AND CONDENSER FAN BLADES IN UNIT. COMB OUT COILS TO REPAIR BENT FINS TO THE SATISFACTION TO THE ENGINEER. INSTALL HAIL GUARDS.
  - 2. INSTALL HAIL GUARDS FROM CHILLER MANUFACTURER. COMB OUT COILS TO REPAIR BENT FINS TO THE SATISFACTION TO THE ENGINEER.

CCC CH-1 CCC CH-2

**CHAMPAIGN COUNTY COURTHOUSE HVAC ROOF PLAN**  
 NO SCALE

DATE	NO.	DESCRIPTION

**GHR ENGINEERS AND ASSOCIATES, INC.**  
 Mechanical & Electrical Consulting Engineers  
 1615 South Neil Street, Champaign, Illinois 61820  
 217-356-0536 Business - 217-356-1092 Fax

**CHAMPAIGN COUNTY COURTHOUSE HVAC ROOF PLAN**  
**HAIL DAMAGED HVAC REPLACEMENT**  
 CHAMPAIGN COUNTY  
 1776 E WASHINGTON STREET, URBANA IL 61802

SEAL	DRAWN: JMD	APPROVED: RCVN	SHEET: <b>M-105</b>
	DATE: MAY 05, 2021	ISSUED FOR BID	
	PROJECT: GHR # 7321		